
 


 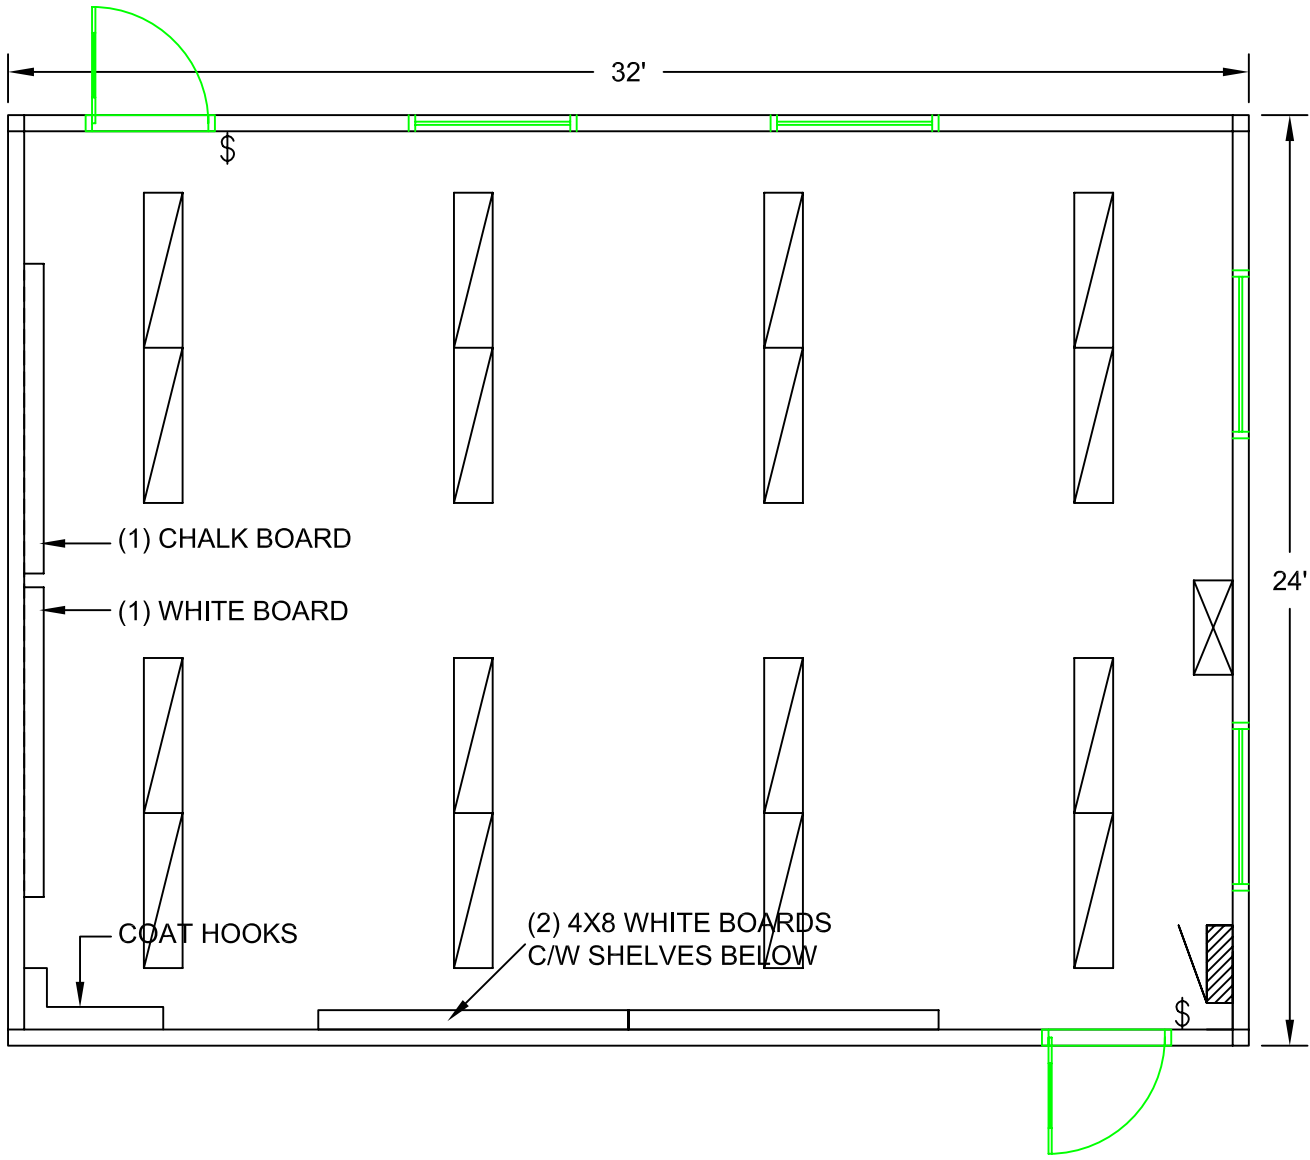


REVISIONS			
REV	DESCRIPTION	Date	APPROVED



ELECTRICAL LEGEND:

-  1'x4' FLUORESCENT LIGHT FIXTURE
-  SINGLE POLE LIGHT SWITCH
-  SERVICE PANEL
-  CHANGE AIR UNIT VENTILATOR

CUSTOMER: _____

LOCATION: _____

JOB NAME: _____

24' X 32' PORTABLE

DWG/JOB NO: ----- BY: E.W.

QUOTE NO: ----- YR MO DY

SHEET NO: 1 07 12 10

SCALE: N.T.S. REV.NO 0

